


BUILDING DESIGN CRITERIA	EXTERNAL DIMENSIONS - 6.0m x 3.0m
Wind Load - in Accordance with AS.1170.2.2002	INTERNAL DIMENSIONS - 5.85m x 2.85m = 16.67m²
REGION A, TERRAIN CATEGORY 2	EXTERNAL AREA - 18 m²
Annual Probability of Exceedance 1:500	EXTERNAL PERIMETER - 18m
REGIONAL WIND SPEED - V500 = 45 m/s	CEILING HEIGHT - 2.4m
Built To: BUILDING CLASS 9a	

FIRE LEGEND		
DESCRIPTION	QTY	
SMOKE DETECTOR : HARD WIRED	1	☒
MISCELLANEOUS	0	⌀

ELECTRICAL LEGEND		
DESCRIPTION	QTY	
CIRCUIT BREAKER BOARD : (POINT of ENTRY)	1	⚡➡
SWITCH : LIGHT : DOUBLE	1	⌀
LIGHT : 2x36w FLUORESCENT : DIFFUSED	2	☒
LIGHT : EXTERNAL BULKHEAD : W/PROOF	1	☒
GPO : 10 AMP DOUBLE : HEIGHT SHOWN	5	⚡
GPO : 15 AMP SINGLE : HEIGHT SHOWN	1	⚡
FAN : EXHAUST : WALL MOUNTED	1	☒
0amps TOTAL BUILDING AMPAGE - SINGLE PHASE		

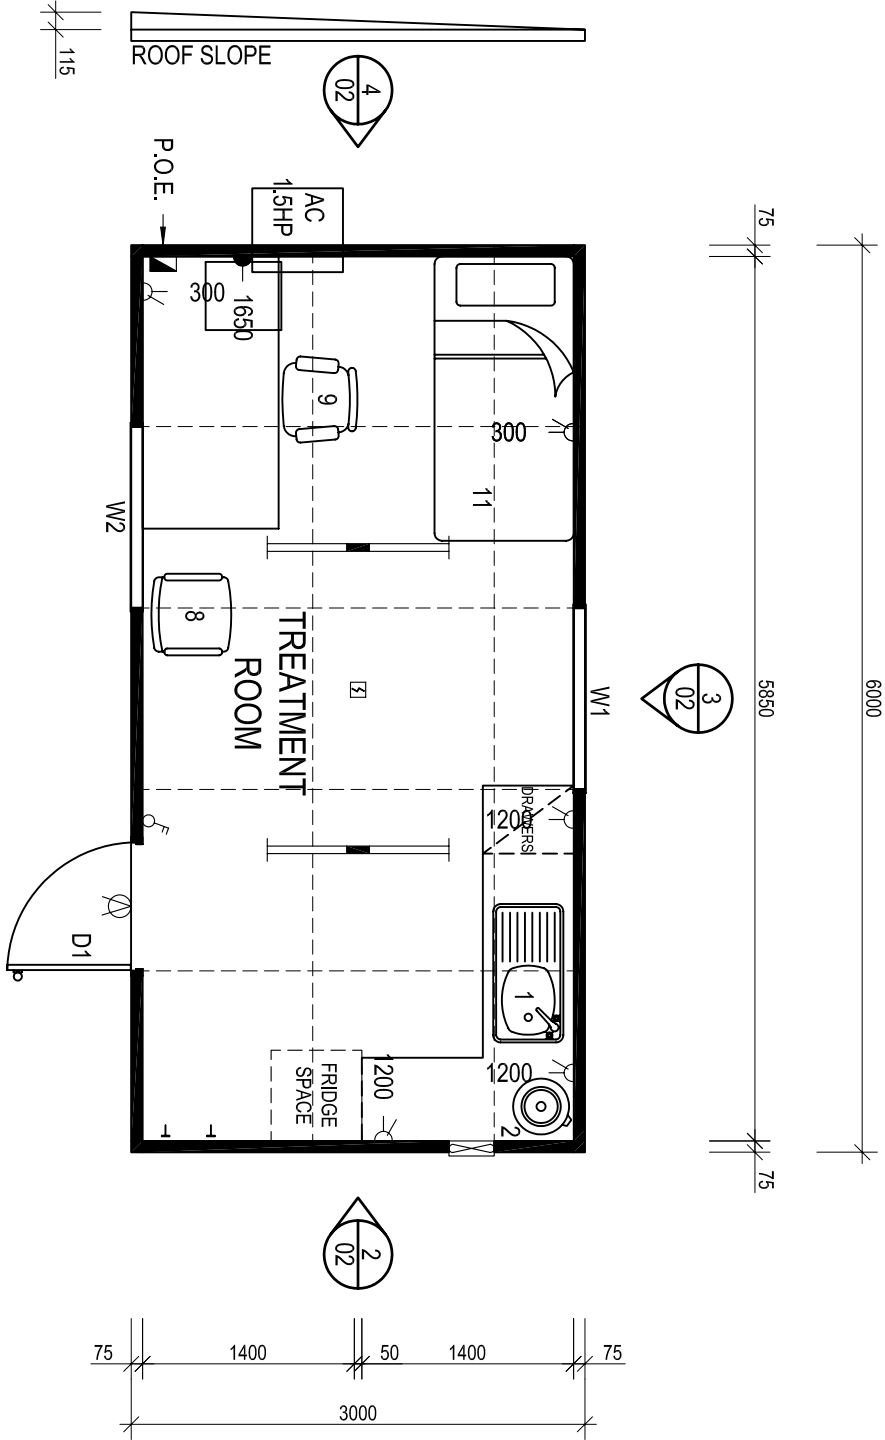

PLAN VIEW

scale 1:50

EQUIPMENT LIST	
No.	DESCRIPTION
D1	2040h x 820w PLAIN METAL EXTERNAL DOOR
W1	1050h x 1190w HORIZ. SLIDING WINDOW c/w FLYSCREEN & Vertical Blinds
AC	WALL MOUNTED REVERSE CYCLE AIR CONDITIONER (1.5 HP)
1	600 WIDE LAM. BENCH c/w 930w SINGLE BOWL S.S. SINK INSET & CUPBOARD UNDER
2	25 LITRE HOT WATER SYSTEM - UNDER BENCH
7	COAT HOOK
8	VISITOR CHAIR
9	1800 x 900mm DESK & DRAWERS with OFFICE CHAIR
11	SINGLE BED

PANEL BUILDING SHORT SPECIFICATION

- CHASSIS - STEEL BEAMS c/w GALV. JOISTS 75 x 40 CEE SECTIONS @ MAX 400 CTRS
- FLOORING - 22mm T&G AQUATITE TERMITTE TREATED PARTICLE BOARD
- FLOOR COVERING - 1.5mm VINYL FLOOR FINISH
- 2.0mm SLIP RESISTANT VINYL FLOOR FINISH c/w 100mm HIGH COVING TO WET AREAS
- EXTERNAL WALLS - 75mm PANEL c/w 0.4mm COLORBOND facings - refer colour schedule
- INTERNAL WALLS - 50mm PANEL c/w 0.4mm COLORBOND facings - refer colour schedule
- ROOF INSULATION - R1.8 POLYESTER INSULATION between ceiling joists with
- THERMALBREAK under roof sheets - TOTAL ROOF RATING R3.6
- ROOF & CEILING FRAME - GALV. STEEL FRAMEWORK
- ROOF CLADDING - SUPERDEK SHEETING - refer colour schedule
- CEILING - PRE-FINISHED PLYWOOD c/w ALUMINIUM CORNICE
- ROOF FLASHINGS & CORNER TRIMS - COLORBOND - refer colour schedule
- DOOR FRAMES - METAL POWDERCOATED FINISH - refer colour schedule
- INTERNAL DOOR FRAMES - ALUMINIUM POWDERCOATED FINISH - refer colour schedule

COLOUR SCHEDULE

- ROOF DECKING
- ROOF FLASHING
- EXTERNAL WALLS
- INTERNAL WALLS / DOORS
- CEILING
- WINDOWS
- EXTERNAL DOOR FRAME
- VINYL
- VINYL TO WET AREAS
- CUPBD DOOR & SIDES
- CUPBD TOP & SHELVES
- LOGOS
- PERIMETER / BASE CHANNEL
- COLORBOND
- DEEP OCEAN
- PAPER BARK
- SURFMIST
- MIRAGE PEARL
- DEEP OCEAN
- DEEP OCEAN
- SLATE GREY
- WOODLAND GREY
- SOFT LEMON
- WHITE
- YES
- BLACK OXIDE

1240 ABERNETHY RD HIGH WYCOMBE W.A. 6057

PH: (08) 9281 7500 FAX: (08) 9281 7580

EMAIL: info@fleetwood.com.au

INTERSTATE BRANCHES:

DALGETTY RD ALICE SPRINGS N.T. 0870 PH: 8952 1699 FAX: 8952 1177

58 MCKINNON RD. BERRI MAH, DARWIN N.T. 0820 PH: 8932 4900 FAX: 8932 4888

HEAD OFFICE

1240 ABERNETHY RD HIGH WYCOMBE W.A. 6057

PH: (08) 9281 7500 FAX: (08) 9281 7580

EMAIL: info@fleetwood.com.au

INTERSTATE BRANCHES:

DALGETTY RD ALICE SPRINGS N.T. 0870 PH: 8952 1699 FAX: 8952 1177

58 MCKINNON RD. BERRI MAH, DARWIN N.T. 0820 PH: 8932 4900 FAX: 8932 4888

THIS DRAWING IS PROTECTED BY COPYRIGHT LAWS © 2009

DO NOT SCALE: REFER TO DIMENSIONS ONLY

A	QUOTATION	DD	10-02-10
REV	DESCRIPTION	INT	DATE
DRAWN BY:	DATE:	CHECKED BY:	DATE:
DD	10-02-10		1:50

LOCATION: TBA

TITLE: FIRST AID ROOM 6.0m x 3.0m - PLAN VIEW

DWG No: B01 -01

JOB No:

REV: A

SHEET: A3